


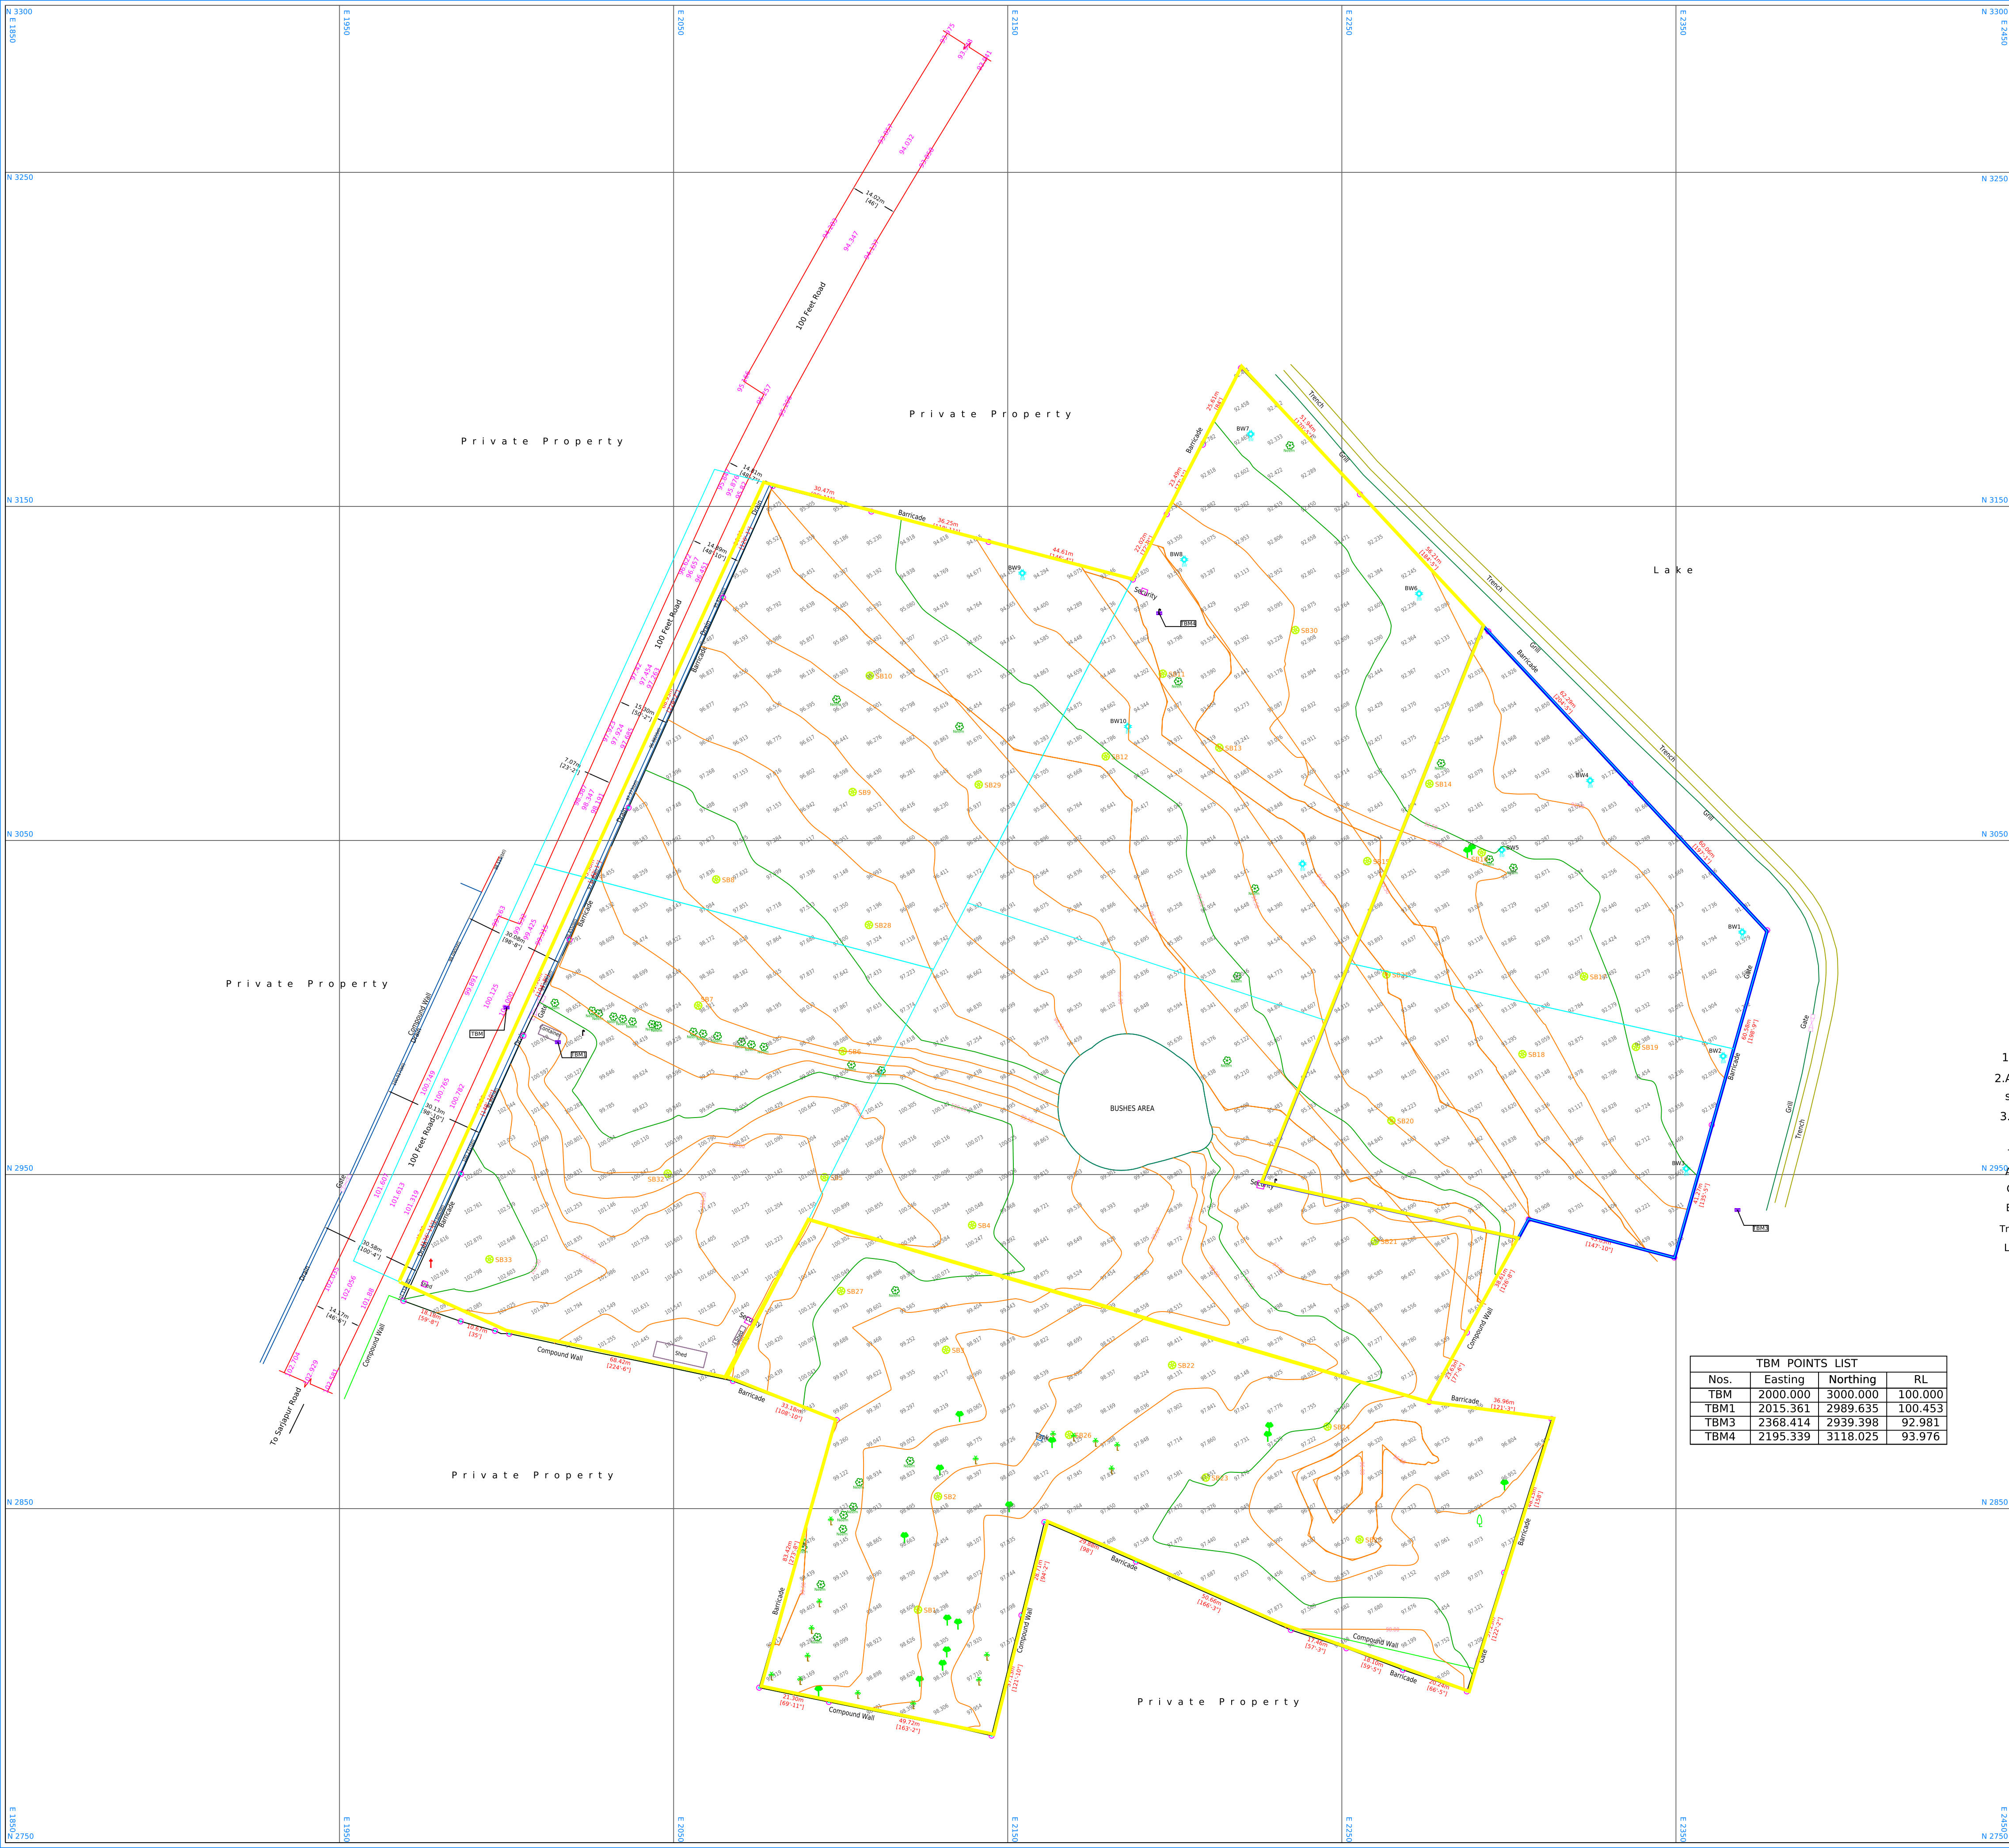

TBM POINTS LIST			
Nos.	Easting	Northing	RL
TBM1	2000.000	3000.000	100.000
TBM2	2015.361	2989.635	100.453
TBM3	2368.414	2939.398	92.981
TBM4	2195.339	3118.025	93.976

North:-

Scale:- 1:1000(1Cm =10.00M)

- Notes:-
- All Dimension & levels are in meters,
 - A Bench mark has been established On Road as shown and assigning it to a TBM - 100.000 arbitrarily
 - Spot Levels taken at 10 mtr

LEGEND

TBM ,Vertex, Boundary	
Asphalt Road , Pathway , Drain	
Camera Pole, Soil Test Point,EP	
Bore Well, Barricade, Grill, Trench	
Trees: Coconut, Neem,Eucalyptus & Others	
Levels:-Road, Spot & Bottom, Contour	

AREA STATEMENT

97568.07 Sqmt / 1050214.00 Sqft
Acres=24 Guntas=4.36

TITLE:-

Topographical Land Survey For The Site
@ Syno: 109,110, 111, 112,114, 113, 115 116
Of Sarjapur Road
Carmelaram, Chikkabellandur
Bangalore, Karnataka - 560035.

CLIENT:-

M/s.APARNA CONSTRUCTION
Carmelaram, Chikkabellandur
Bengaluru

Drawing No:- GMC: 104 - R0	
Reff : Sys5/D/Aparna Sarjapura - 26-06-2024	
Season: June - 2024	
SURVEYED BY	SURVEYED ON
Ajay	24&26 -06-2024
DRAWN BY	CHECKED BY
Girish	Sadullah R

CONSULTANTS:-

GEO-METAGE CONSULTANTS INC
74, 3rd Main, 1st Stage, 1st Phase
West of Chord Road, Service Road
Manjunathnagar
Bangalore-10
Mob:9845151801